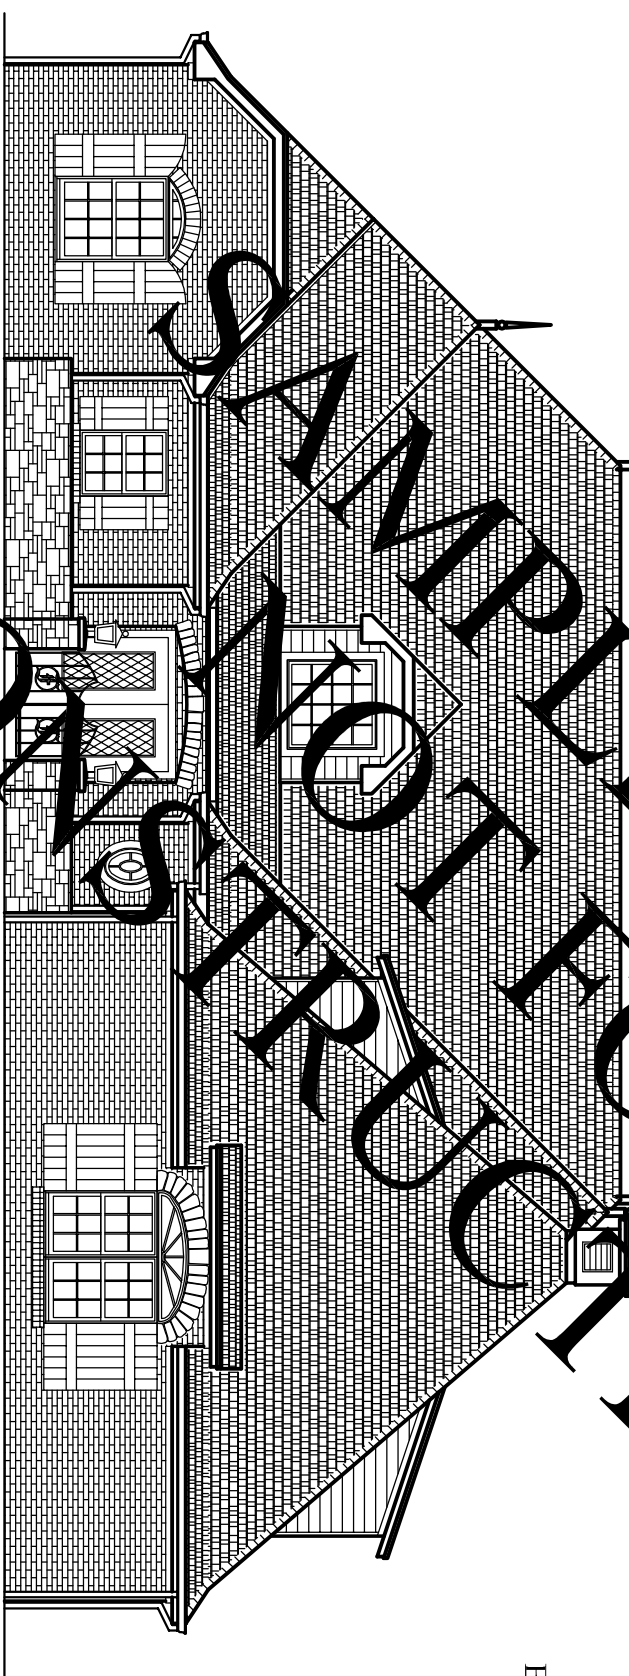




 



BOB & TINNA

FRITTS

 


CUSTOM HOME PLANS LAWTON, OKLAHOMA



 
 
 
 
 


 


 





MISCELLANEOUS SYMBOLS

-  Furnace Location
-  Water Heater Location
-  Window Location
-  Bubble (Corresponds To Information In Window Schedule)
-  Door Location
-  Bubble (Corresponds To Information In Door Schedule)

-  Indicates Direction Of View
-  Detail and Section No.
-  Reference Sheet No.
-  Current Sheet No.

-  Size Of Ceiling Joists
-  Direction Of Joists
-  Spacing Of Joists

ELECTRICAL LEGEND

-  120V Duplex Plug
-  120V Quadplex Plug
-  240V Outlet
-  Single Pole Switch
-  Three Pole Switch
-  Telephone Jack
-  Panel Box
-  Incandescent Light Fixture
-  Recessed Incand. Light Fixture
-  Ceiling Fan
-  Tracklight Fixture
-  Flood Light Fixture
-  Ceiling Header
-  Ceiling Exhaust Fan
-  24x 48 Fluorescent Fixture
-  Single Fluorescent Fixture

USE & OCCUPANCY CLASSIFICATION	3130 sq.ft.
DESIGN OCCUPANCY LOAD	TYPE R3
DESIGN OCCUPANCY TYPE	VB
DESIGN OCCUPANCY LOAD	16 OCCUPANTS


INDEX OF SHEETS

TITLE SHEET	1 OF 11
SITE PLAN	2 OF 11
1st FLOOR PLAN	3 OF 11
2nd FLOOR PLAN	4 OF 11
EXTERIOR ELEVATIONS	5 OF 11
FOUNDATION PLAN	6 OF 11
CABINET DETAILS1	7 OF 11
CABINET DETAILS2	8 OF 11
BUILDING SECTIONS	9 OF 11
ROOF PLAN	10 OF 11
ELECTRICAL PLAN	11 OF 11

1) All construction to be done in accordance with federal, state, and local building codes. Loveday Designs assumes no responsibility for the construction quality or compliance as performed by the building contractor or contractors.

2) All information contained in this set is copyrighted as of the date of last revision, and is the property of Loveday Designs. These plans are to be used only for the project for which they were originally created.

Copyright Loveday Designs 2005



**LOVEDAY
DESIGNS**

1217 North 11th Street
Duncan, OK. 73533

Phone (580) 252-0489
djl@loveday@sbcglobal.net

*For every house is built by some man: but he that built all things is God. Hebrews 3:4